





Annex D_Drawing/Plan

Name of Project: **COMPLETION OF THE REHABILITATION OF OLD TECH-VOC BUILDING**

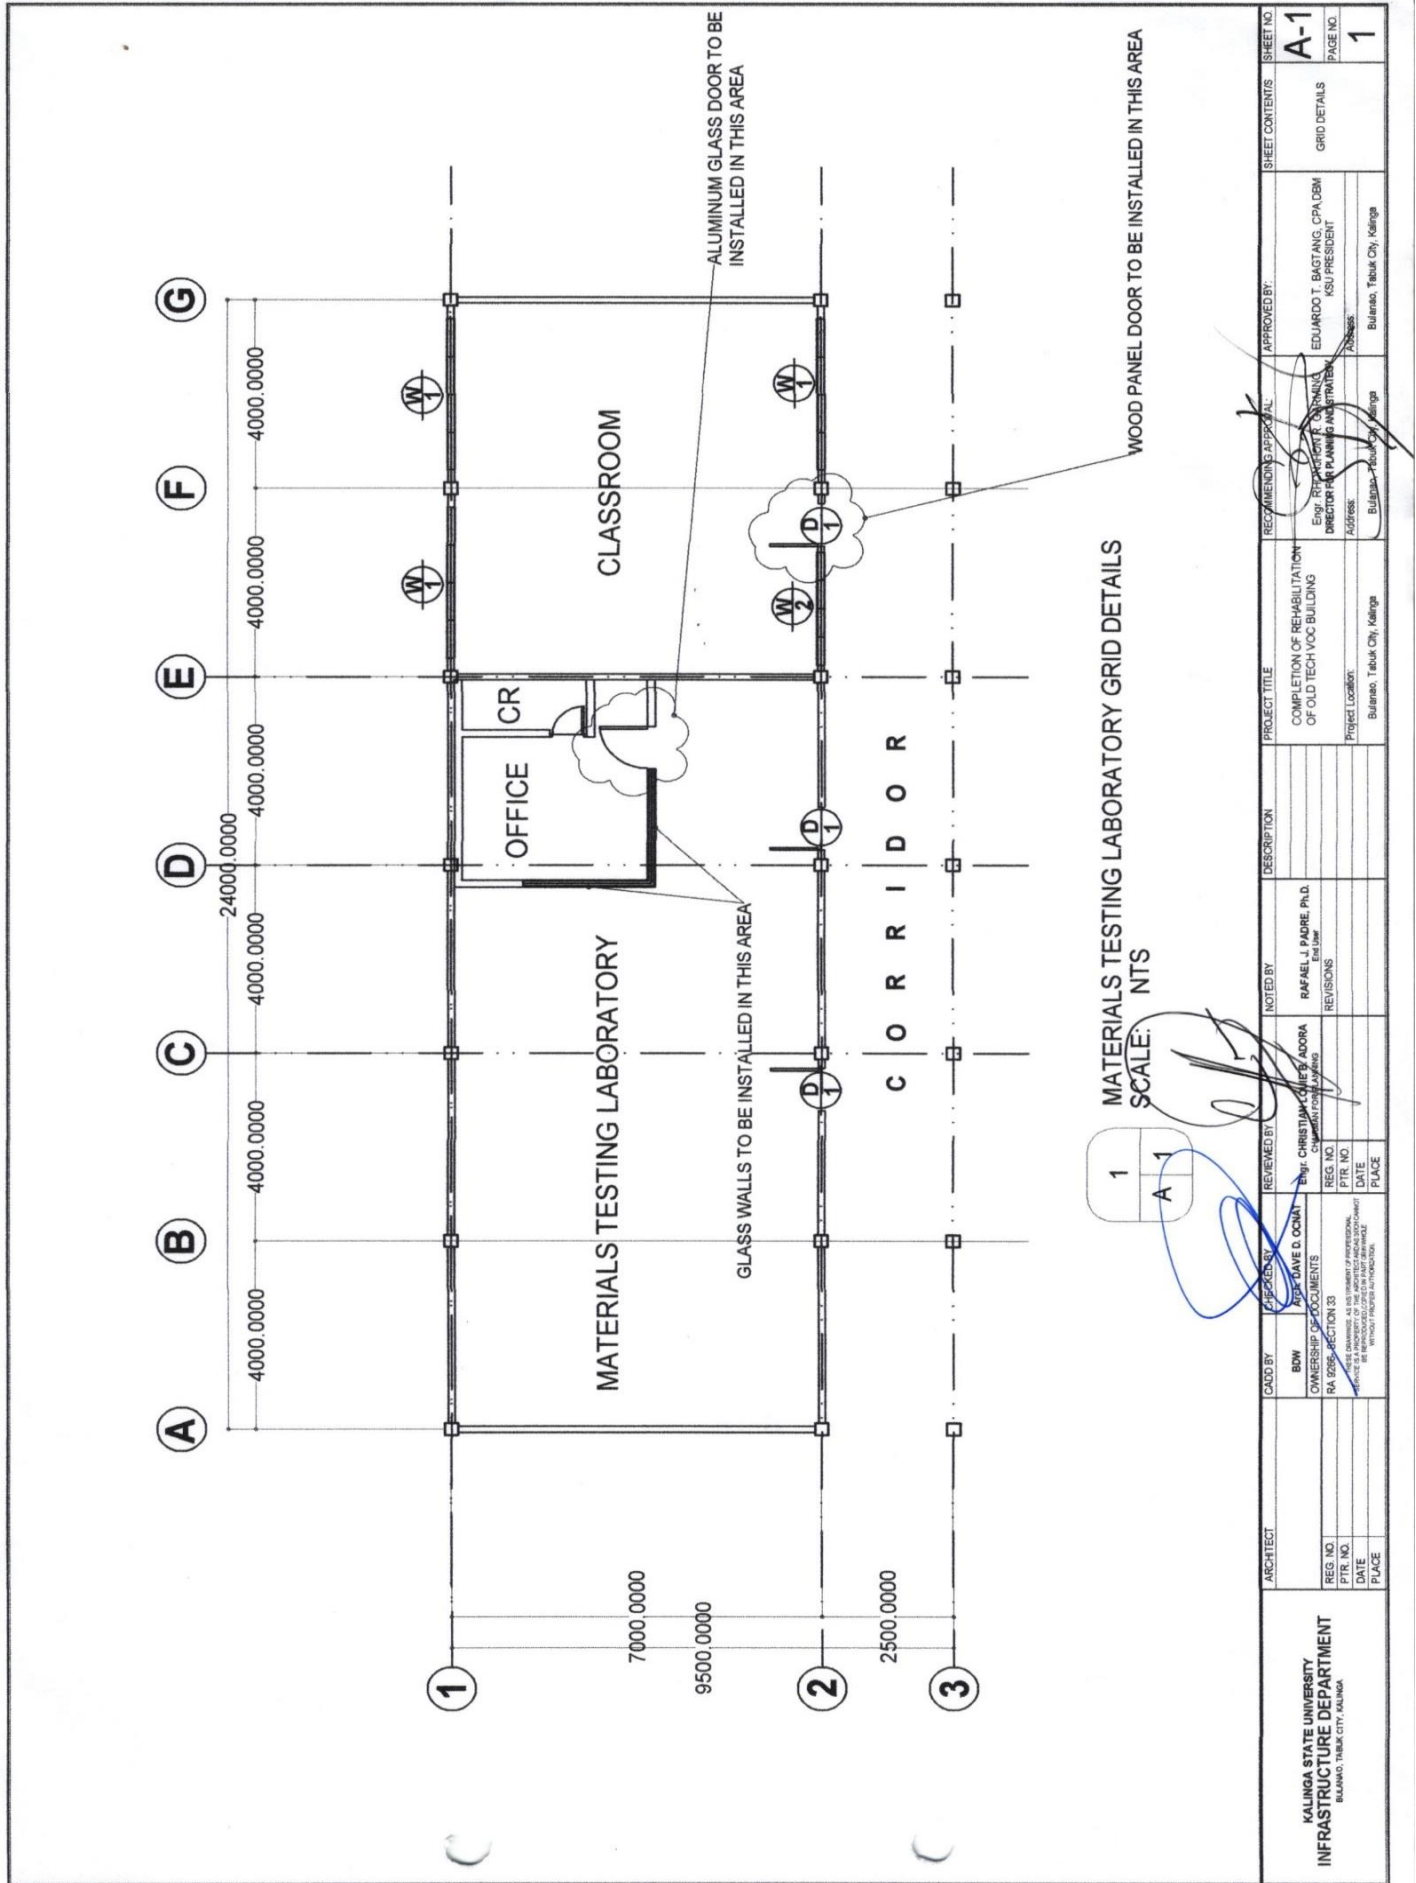



Republic of the Philippines
KALINGA STATE UNIVERSITY
BIDS AND AWARDS COMMITTEE
 National Highway, Purok 6, Bulanao, Tabuk City, Kalinga
 Website: <https://ksu.edu.ph> Email: procurementservice_bac@ksu.edu.ph Tel. No.: (074)627-5321

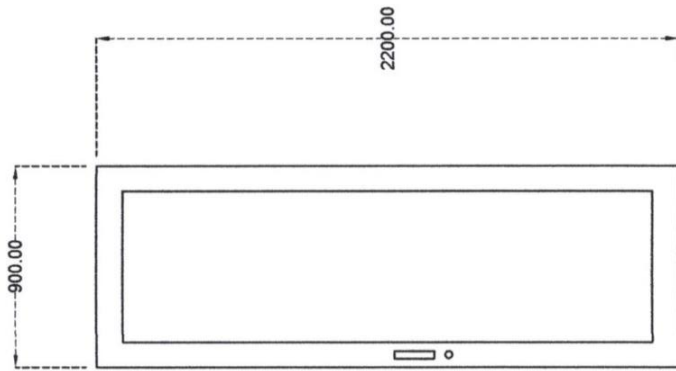

DESCRIPTION	ALUMINUM GLASS DOOR, 2200x900 6 mm THICK, CLEAR GLASS
LOCATION	MATERIALS TESTING LABORATORY OFFICE
REQUIREMENTS	1 SET
HARDWARE	COMPLETE LOCKSET COMPLETE HINGES AND ACCESSORIES


3
A 2
GLASS DOOR SCHEDULE
 SCALE 1:20 m.



2
A 2
LOCKSET DETAILS
 SCALE 1:2 m.

DESCRIPTION	WOOD PANEL DOOR 2100x900 WELL SEASONED DOOR, VARNISH FINISH
LOCATION	CLASSROOM BESIDE MATERIALS TESTING LABORATORY
REQUIREMENTS	1 SET
HARDWARE	HEAVY DUTY DOOR KNOB COMPLETE HINGES AND ACCESSORIES


1
A 2
WOOD PANEL DOOR DETAILS
 SCALE 1:20 m.

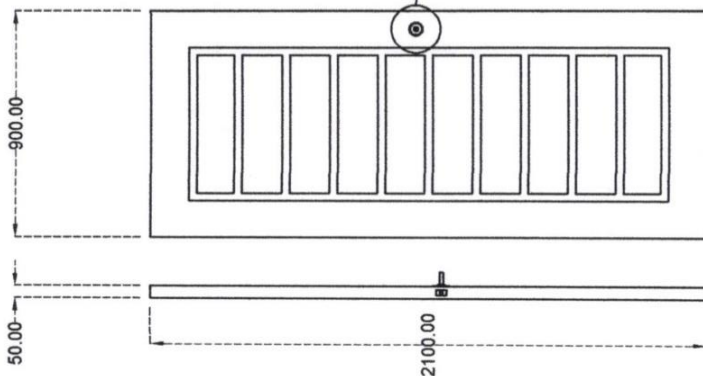

KALINGA STATE UNIVERSITY INFRASTRUCTURE DEPARTMENT <small>BULANAO, TABUK CITY, KALINGA</small>	ARCHITECT REG. NO. _____ PTR. NO. _____ DATE _____ PLACE _____	CADED BY BOW <small>OWNERSHIP DOCUMENTS</small> RA 8206-SECTION 33 <small>REGISTERED AS AN ARCHITECT OF PROFESSIONAL ENGINEER AS AUTHORIZED OFFICER IN CHARGE OF THE PROJECT AS AUTHORIZED INDIVIDUAL</small>	REVIEWED BY Engr. CHRISTIAN JAY E. ADORA <small>CHIEF ARCHITECT PLANNING</small> REG. NO. _____ PTR. NO. _____ DATE _____ PLACE _____	NOTED BY RAFAEL J. PADRE, Ph.D. <small>Enr. Ltr.</small> REVISIONS _____	PROJECT TITLE COMPLETION OF REHABILITATION OF OLD TECH VOC BUILDING Project Location: Bulanao, Tabuk City, Kalinga	RECOMMENDED BY Engr. RICHARD T. BAYANG <small>DIRECTOR FOR PLANNING AND STRATEGY</small> Address: Bulanao, Tabuk City, Kalinga	APPROVED BY EDUARDO T. BAGTANG, CPA, DBM <small>KSU PRESIDENT</small> Address: Bulanao, Tabuk City, Kalinga	SHEET NO. A-2 PAGE NO. 2
--	--	--	--	--	---	--	---	---



Republic of the Philippines
KALINGA STATE UNIVERSITY
BIDS AND AWARDS COMMITTEE
 National Highway, Purok 6, Bulanao, Tabuk City, Kalinga
 Website: <https://ksu.edu.ph> Email: procurementservice_bac@ksu.edu.ph Tel. No.: (074)627-5321

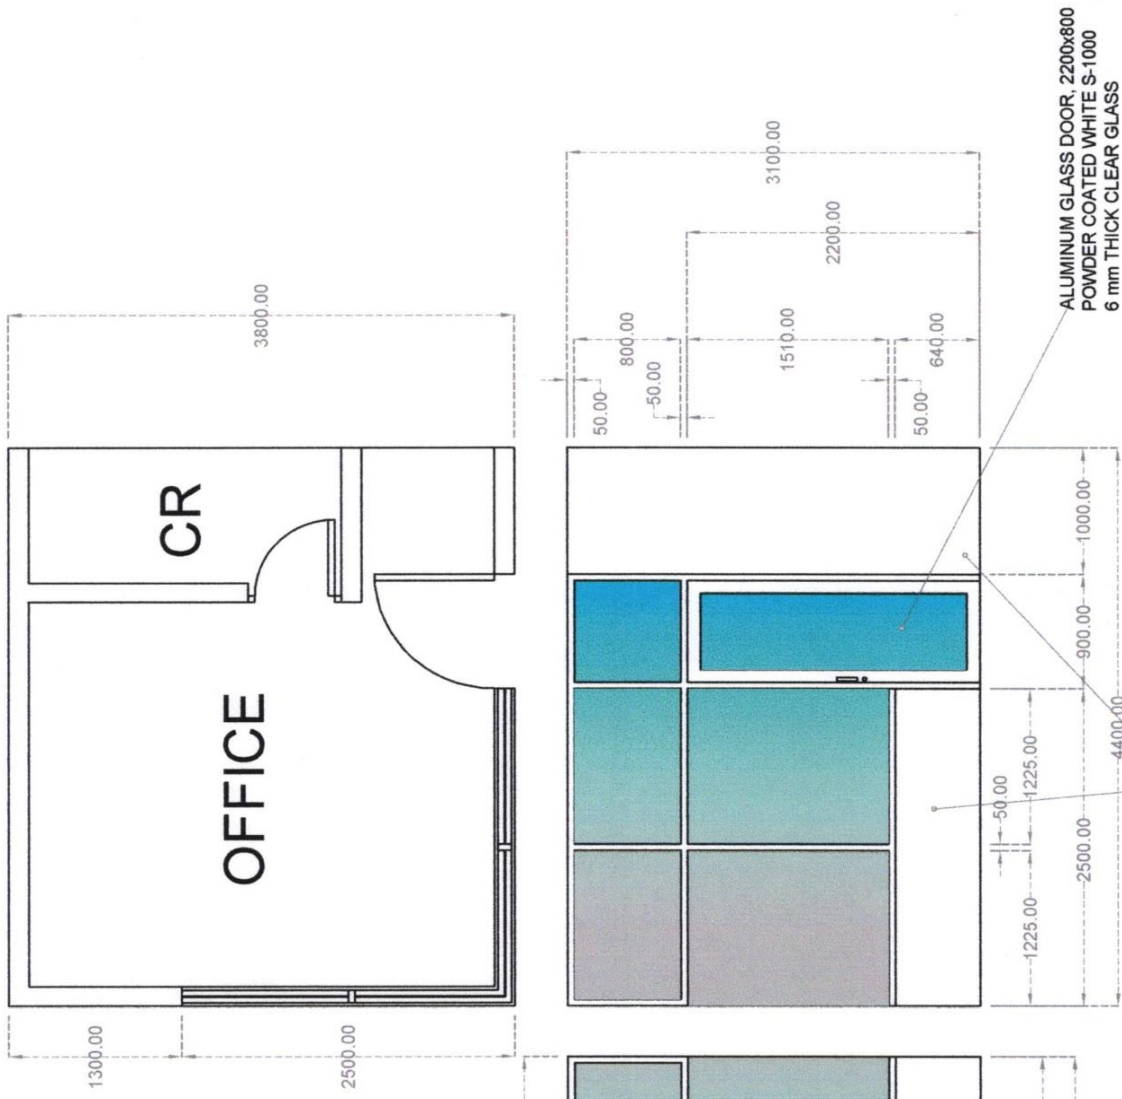


1 GLASS WALL DETAILS
 A 3 SCALE 1:40 m.

6 mm THICK, CLEAR FIXED GLASS
POWDER COATED WHITE, SERIES 1000

ALUMINUM GLASS DOOR, 2200x800
POWDER COATED WHITE S-1000
6 mm THICK CLEAR GLASS

EXISTING CONCRETE STRUCTURE

ARCHITECT	OWNER	DESIGNER	NOTED BY	REVIEWED BY	CHECKED BY	DATE	PLACE	PROJECT TITLE	RECOMMENDING APPROVAL	APPROVED BY:	SHEET CONTENTS	SHEET NO.
KALINGA STATE UNIVERSITY INFRASTRUCTURE DEPARTMENT BULANAO, TABUK CITY, KALINGA	BSW OWNERSHIP DOCUMENTS RAJARES SECTION 33 THESE DRAWINGS ARE THE PROPERTY OF PROFESSIONAL SERVICE INC. AND SHALL BE KEPT IN STRICT CONFIDENCE AND NOT TO BE REPRODUCED OR TRANSMITTED IN ANY FORM OR BY ANY MEANS WITHOUT WRITTEN PERMISSION FROM THE ARCHITECT.	Engr. CHRISTIAN LOPEZ ADORA CHIEF ARCHITECT	Engr. RAFAEL J. PADRE, P.L.D. Engr. LUIS M. REYES REVISIONS	Engr. CHRISTIAN LOPEZ ADORA CHIEF ARCHITECT	Engr. RAFAEL J. PADRE, P.L.D. Engr. LUIS M. REYES REVISIONS			COMPLETION OF REHABILITATION OF OLD TECH VOC BUILDING Project Location: Bulanao, Tabuk City, Kalinga	Engr. EDUARDO T. BACANTANG, CPA, DBM KSU PRESIDENT Address: Bulanao, Tabuk City, Kalinga	EDUARDO T. BACANTANG, CPA, DBM KSU PRESIDENT Address: Bulanao, Tabuk City, Kalinga	GLASS WALL DETAILS	A-3
												3

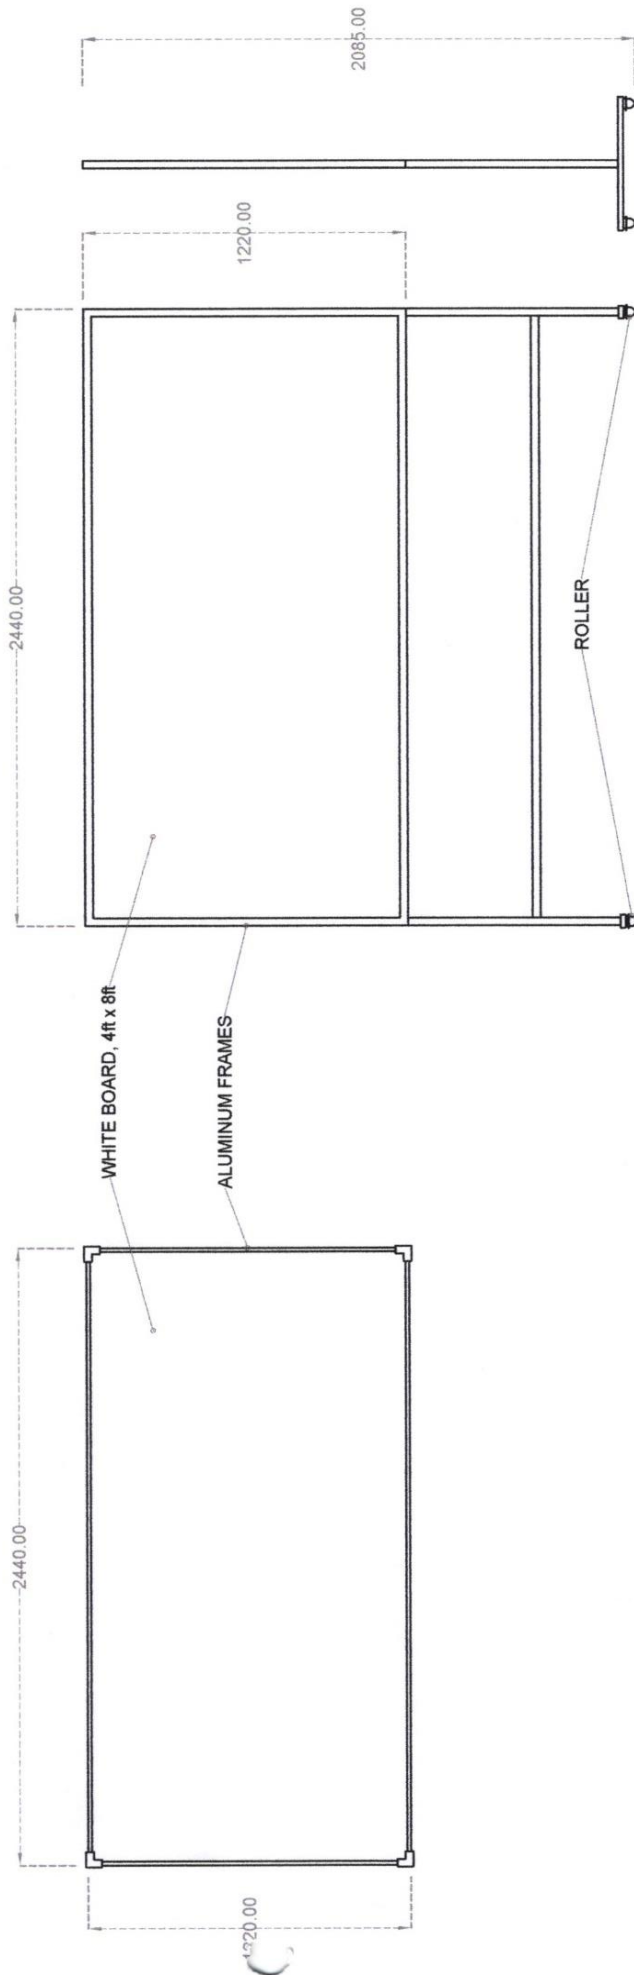


2 WHITE BOARD WITH ROLLER DETAILS
A 4 SCALE 1:20 m.

1 WHITE BOARD DETAILS
A 4 SCALE 1:20 m.

KALINGA STATE UNIVERSITY INFRASTRUCTURE DEPARTMENT BULANAO, TABUK CITY, KALINGA	ARCHITECT REG. NO. PTR. NO. DATE PLACE	CADD BY BOW OWNERSHIP DOCUMENTS RAPPORTS SECTION 33 <small>THESE DRAWINGS ARE THE PROPERTY OF PROFESSIONAL SERVICE INCORPORATED AND ARE TO BE USED ONLY FOR THE PROJECT AND/OR FOR WHICH THEY WERE PREPARED WITHOUT FURTHER AUTHORIZATION.</small>	CHECKED BY Aracely D. DONAT <small>REGISTERED PROFESSIONAL ARCHITECT</small>	REVIEWED BY Engr. CHRISTIAN J. ADORA <small>REGISTERED PROFESSIONAL ARCHITECT</small>	NOTED BY RAFAEL J. PADRE, PH.D. <small>Engr. in Charge</small> REVISIONS	DESCRIPTION COMPLETION OF REHABILITATION OF OLD TECH VOC BUILDING Project Location: Bulanao, Tabuk City, Kalinga	RECOMMENDING APPROVAL Engr. RICHARD T. SARMIWING <small>DIRECTOR FOR PLANNING AND STRATEGY</small> Address: Bulanao, Tabuk City, Kalinga	APPROVED BY EDUARDO T. BAGTANG, CPA, DBM <small>KSU PRESIDENT</small> Address: Bulanao, Tabuk City, Kalinga	SHEET CONTENTS SHEET NO. A-4 PAGE NO. 4 WHITE BOARD DETAIL
---	--	---	---	--	--	--	--	---	---



Republic of the Philippines
KALINGA STATE UNIVERSITY
BIDS AND AWARDS COMMITTEE
 National Highway, Purok 6, Bulanao, Tabuk City, Kalinga
 Website: <https://ksu.edu.ph> Email: procurementservice_bac@ksu.edu.ph Tel. No.: (074)627-5321

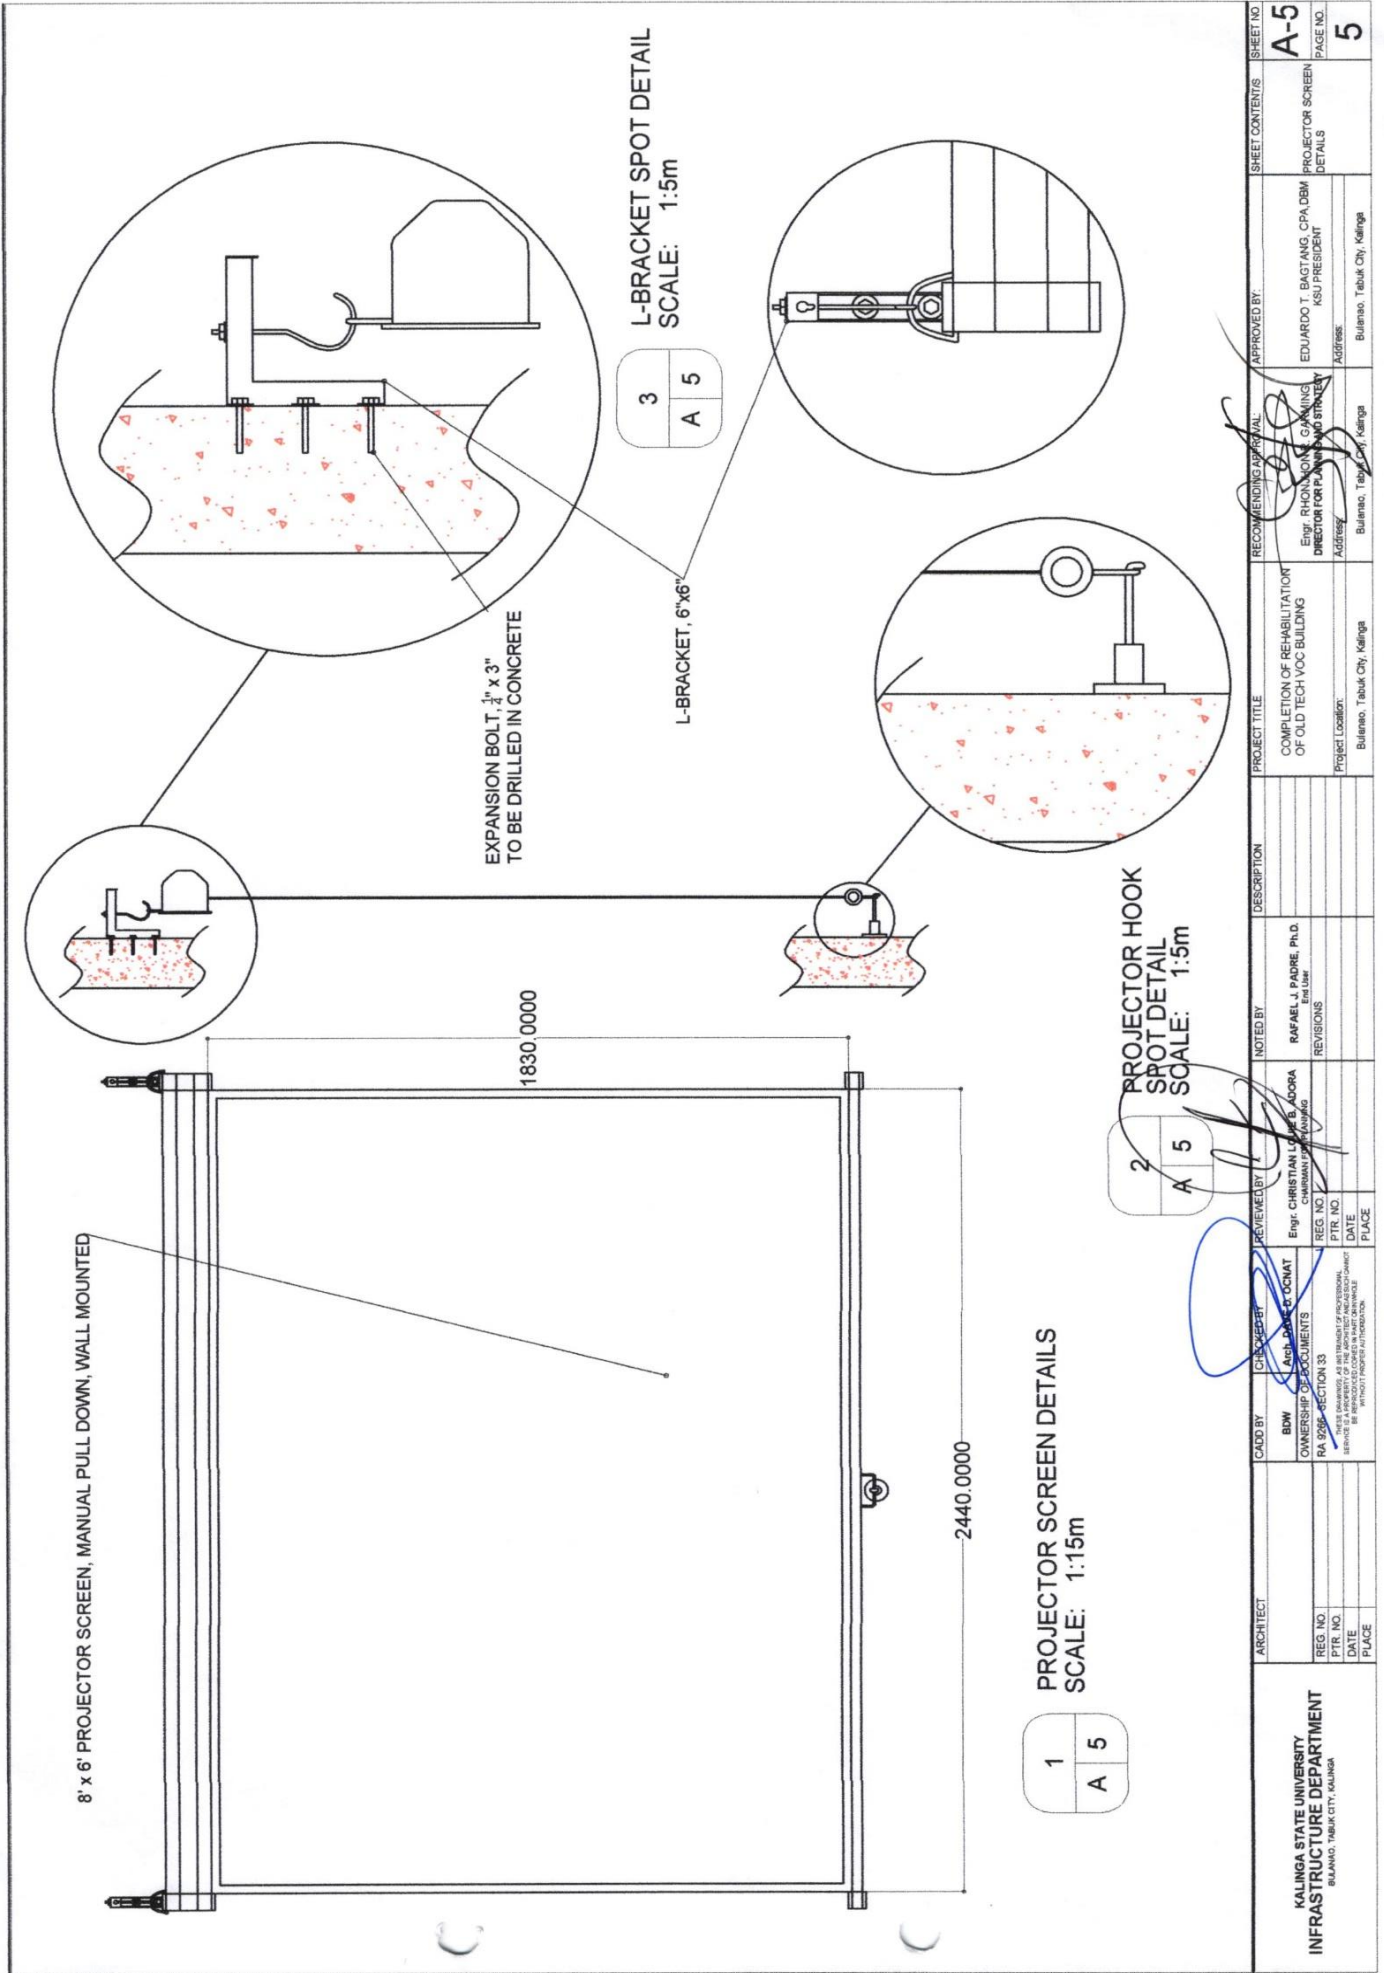


KALINGA STATE UNIVERSITY INFRASTRUCTURE DEPARTMENT BULANAO, TABUK CITY, KALINGA	ARCHITECT REG. NO. PTR. NO. DATE PLACE	CAO BY BOW OWNERSHIP OF DOCUMENTS RA 926-SECTION 33 <small>THESE DRAWINGS ARE THE PROPERTY OF PROFESSIONAL SERVICE INC. REPRODUCTION OR TRANSMISSION IN ANY MANNER WITHOUT PROPER AUTHORIZATION IS PROHIBITED.</small>	CHECKED BY JACK PADE P. OCINAT	REVIEWED BY Engr. CHRISTIAN LOPEZ B. ADORA CHIEF ARCHITECT (Kalinga)	NOTED BY RAFAEL J. PADRE, P.I.D. Enr. URM	DESCRIPTION	PROJECT TITLE COMPLETION OF REHABILITATION OF OLD TECH VOC BUILDING Project Location: Bulanao, Tabuk City, Kalinga	RECOMMENDING APPROVAL Engr. RHONSONE GANANG DIRECTOR FOR PLANNING AND STRATEGY Address: Bulanao, Tabuk City, Kalinga	APPROVED BY EDUARDO T. BAGTANG, CPA, DBM KSU PRESIDENT Address: Bulanao, Tabuk City, Kalinga	SHEET CONTENTS PROJECTOR SCREEN DETAILS	SHEET NO. A-5 PAGE NO. 5
---	---	---	--	---	--	--------------------	---	--	--	---	---




1
A 6
WINDOW 1 DETAILS
SCALE: 1:15

3 SETS OF 3200 mm x 1500 mm SLIDING GLASS WINDOW
 6 mm THICK TINTED GLASS, WITH INTERNAL GRILLS
 ANALOK FRAMES

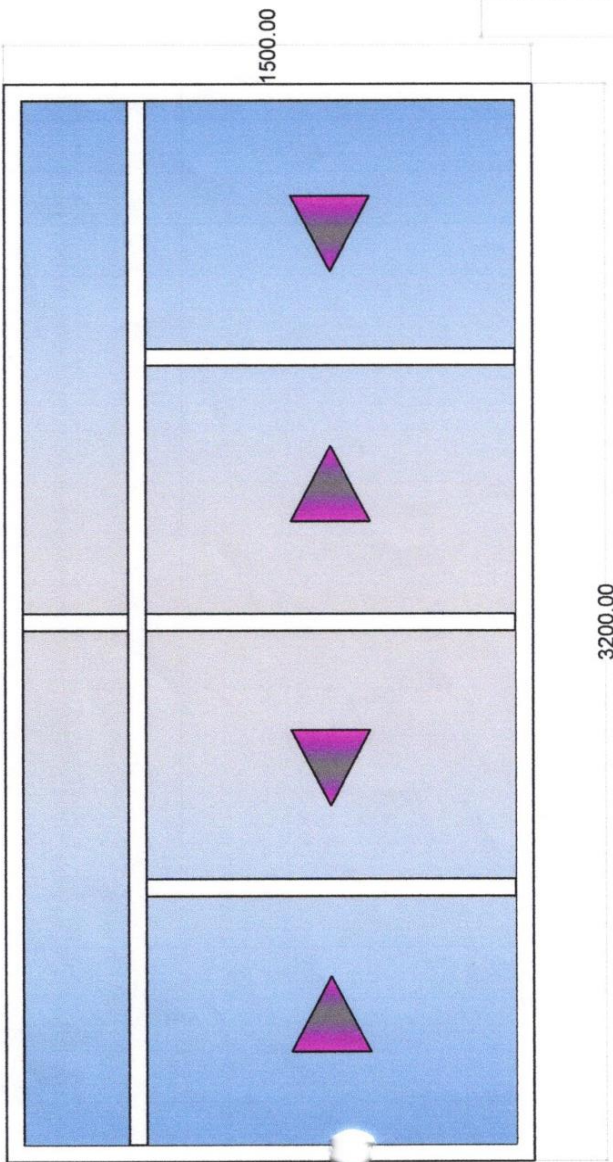

2
A 6
WINDOW 2 DETAILS
SCALE: 1:15


1 SET OF 2400 mm x 1500 mm SLIDING GLASS WINDOW
 6 mm THICK TINTED GLASS, WITH INTERNAL GRILLS
 ANALOK FRAMES

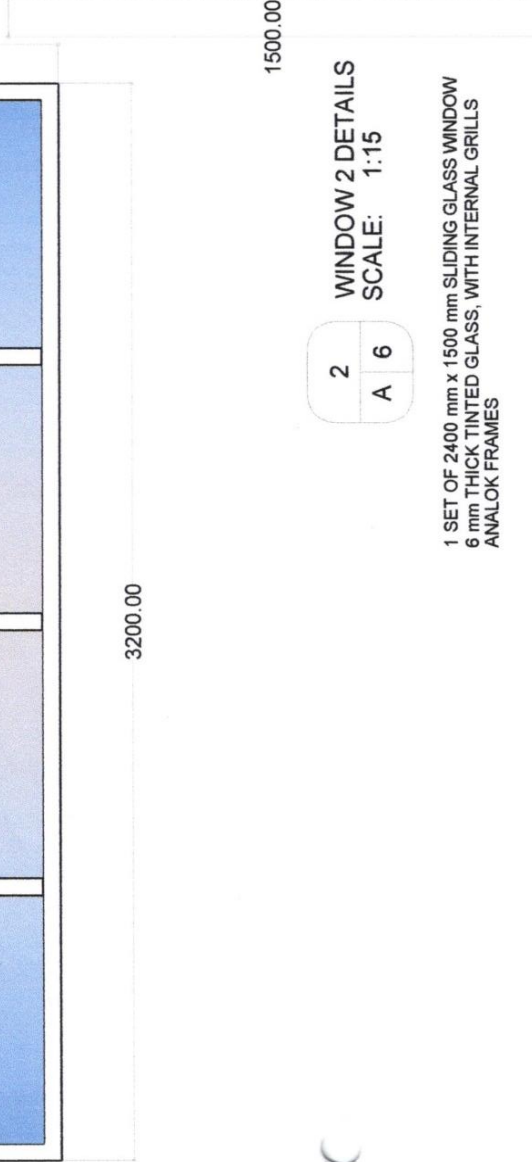

KALINGA STATE UNIVERSITY INFRASTRUCTURE DEPARTMENT <small>BULANAO, TABUK CITY, KALINGA</small>	ARCHITECT REG. NO. PTR. NO. DATE PLACE	CADDED BY BMW OWNERSHIP OF DOCUMENTS RA 6966- SECTION 33 <small>THIS DRAWING IS THE PROPERTY OF PROJECT ENGINEER/ARCHITECT. IT IS TO BE REPRODUCED OR IN ANY MANNER WITHOUT HIS/HER WRITTEN PERMISSION.</small>	REVIEWED BY ENR. DAVID D. OCMAT <small>CHRISTIAN LOPEZ B. ANDRADA</small> <small>CHRISTIAN LOPEZ B. ANDRADA</small> REVISIONS	NOTED BY RAFAEL J. PADRE, PH.D. <small>Enr. User</small> REVISIONS	DESCRIPTION COMPLETION OF REHABILITATION OF OLD TECH YCC BUILDING Project Location: Bulanao, Tabuk City, Kalinga	RECOMMENDING APPROVAL: <small>ENR. RICHARDON R. GARRING</small> DIRECTOR FOR PLANNING AND STUDIES Address: Bulanao, Tabuk City, Kalinga	APPROVED BY: <small>EDUARDO T. BAGTANG, CPA, DBM</small> KSU PRESIDENT Address: Bulanao, Tabuk City, Kalinga	SHEET CONTENTS WINDOW DETAILS	SHEET NO. A-6 PAGE NO. 6
--	--	---	--	--	--	--	---	----------------------------------	---



Republic of the Philippines
KALINGA STATE UNIVERSITY
BIDS AND AWARDS COMMITTEE
 National Highway, Purok 6, Bulanao, Tabuk City, Kalinga
 Website: <https://ksu.edu.ph> Email: procurementservice_bac@ksu.edu.ph Tel. No.: (074)627-5321

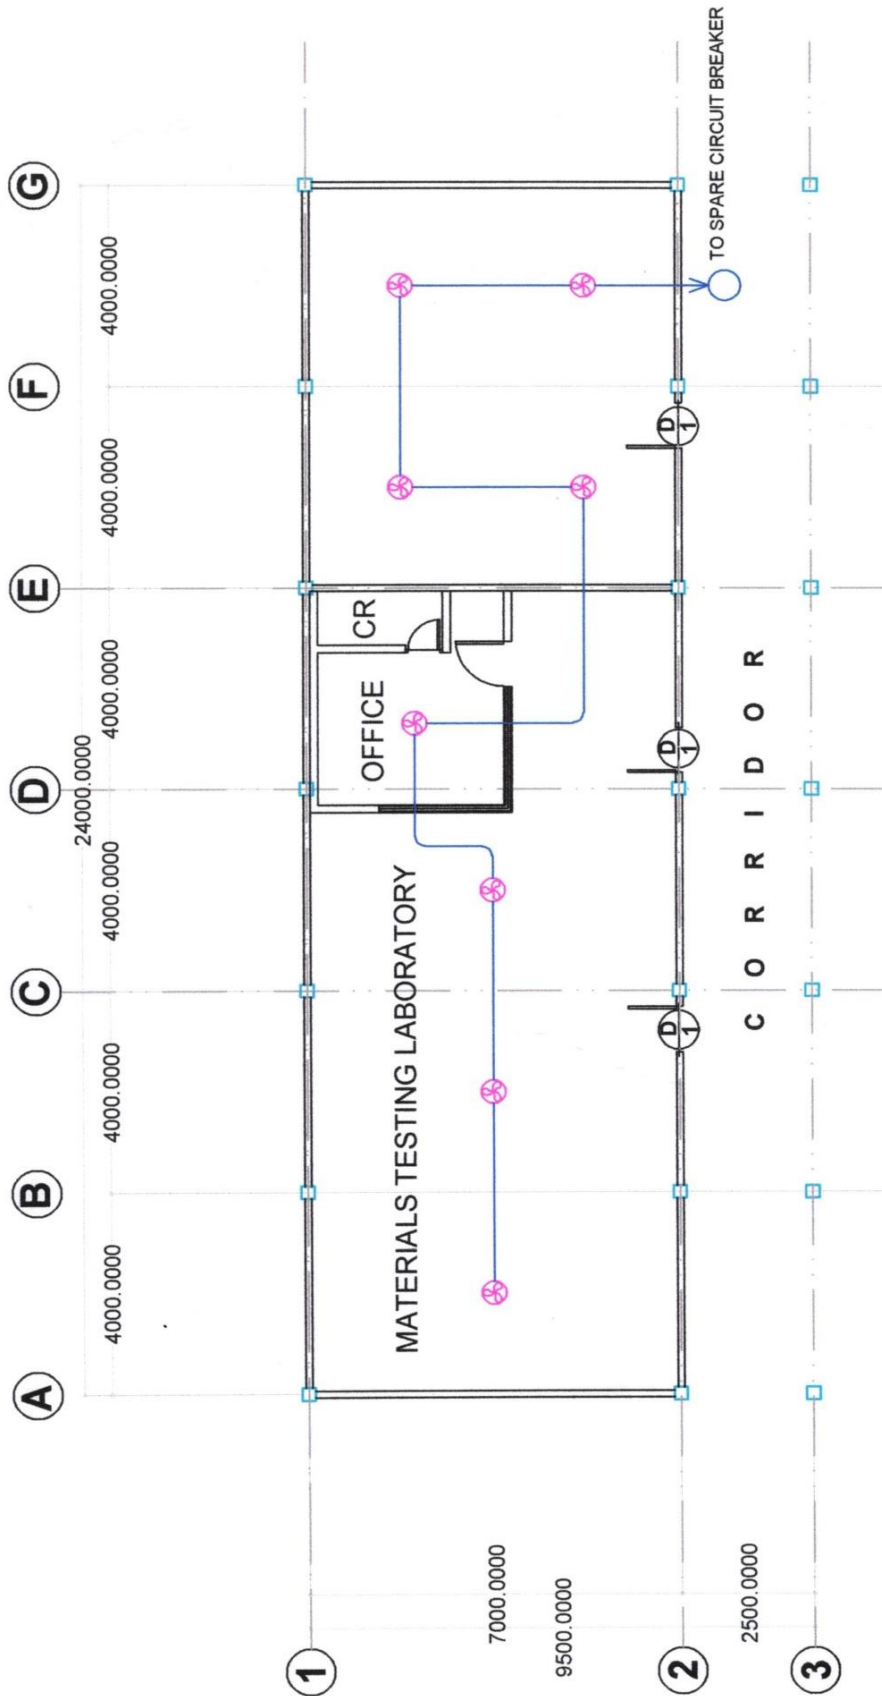

ELECTRICAL LAYOUT FOR CEILING FANS
 SCALE: NTS

1
 E 1

ARCHITECT	CAO'D BY	CHECKED BY	REVIEWED BY	NOTED BY	DESCRIPTION	PROJECT TITLE	RECOMMENDING APPROVAL	APPROVED BY	SHEET CONTENTS	SHEET NO.
KALINGA STATE UNIVERSITY INFRASTRUCTURE DEPARTMENT BULANA, TABUK CITY, KALINGA	BDW OWNERSHIP OF DOCUMENTS RA 9179-SECTION 33 SECURITY OF THE ARCHITECT'S AND ENGINEER'S BY THE BOARD OF PROFESSIONAL REGULATION AND REQUISITIONING	DAVE D. COCAT	CHRISTINA ADORA P. PLANO	RAFAEL J. PADRE, P.D. Engineer REVISIONS	COMPLETION OF REHABILITATION OF OLD TECH VOC BUILDING	COMPLETION OF REHABILITATION OF OLD TECH VOC BUILDING	EDUARDO T. BACTANG, CPA, DBM KSU PRESIDENT	EDUARDO T. BACTANG, CPA, DBM KSU PRESIDENT	ELECTRICAL LAYOUT	E-1
REG. NO. PTR. NO. DATE PLACE	REG. NO. PTR. NO. DATE PLACE	REG. NO. PTR. NO. DATE PLACE	REG. NO. PTR. NO. DATE PLACE	REG. NO. PTR. NO. DATE PLACE	Project Location: Bulanao, Tabuk City, Kalinga	Project Location: Bulanao, Tabuk City, Kalinga	Address: Bulanao, Tabuk City, Kalinga	Address: Bulanao, Tabuk City, Kalinga		7