





**Annex B: Drawing and/or Plan**

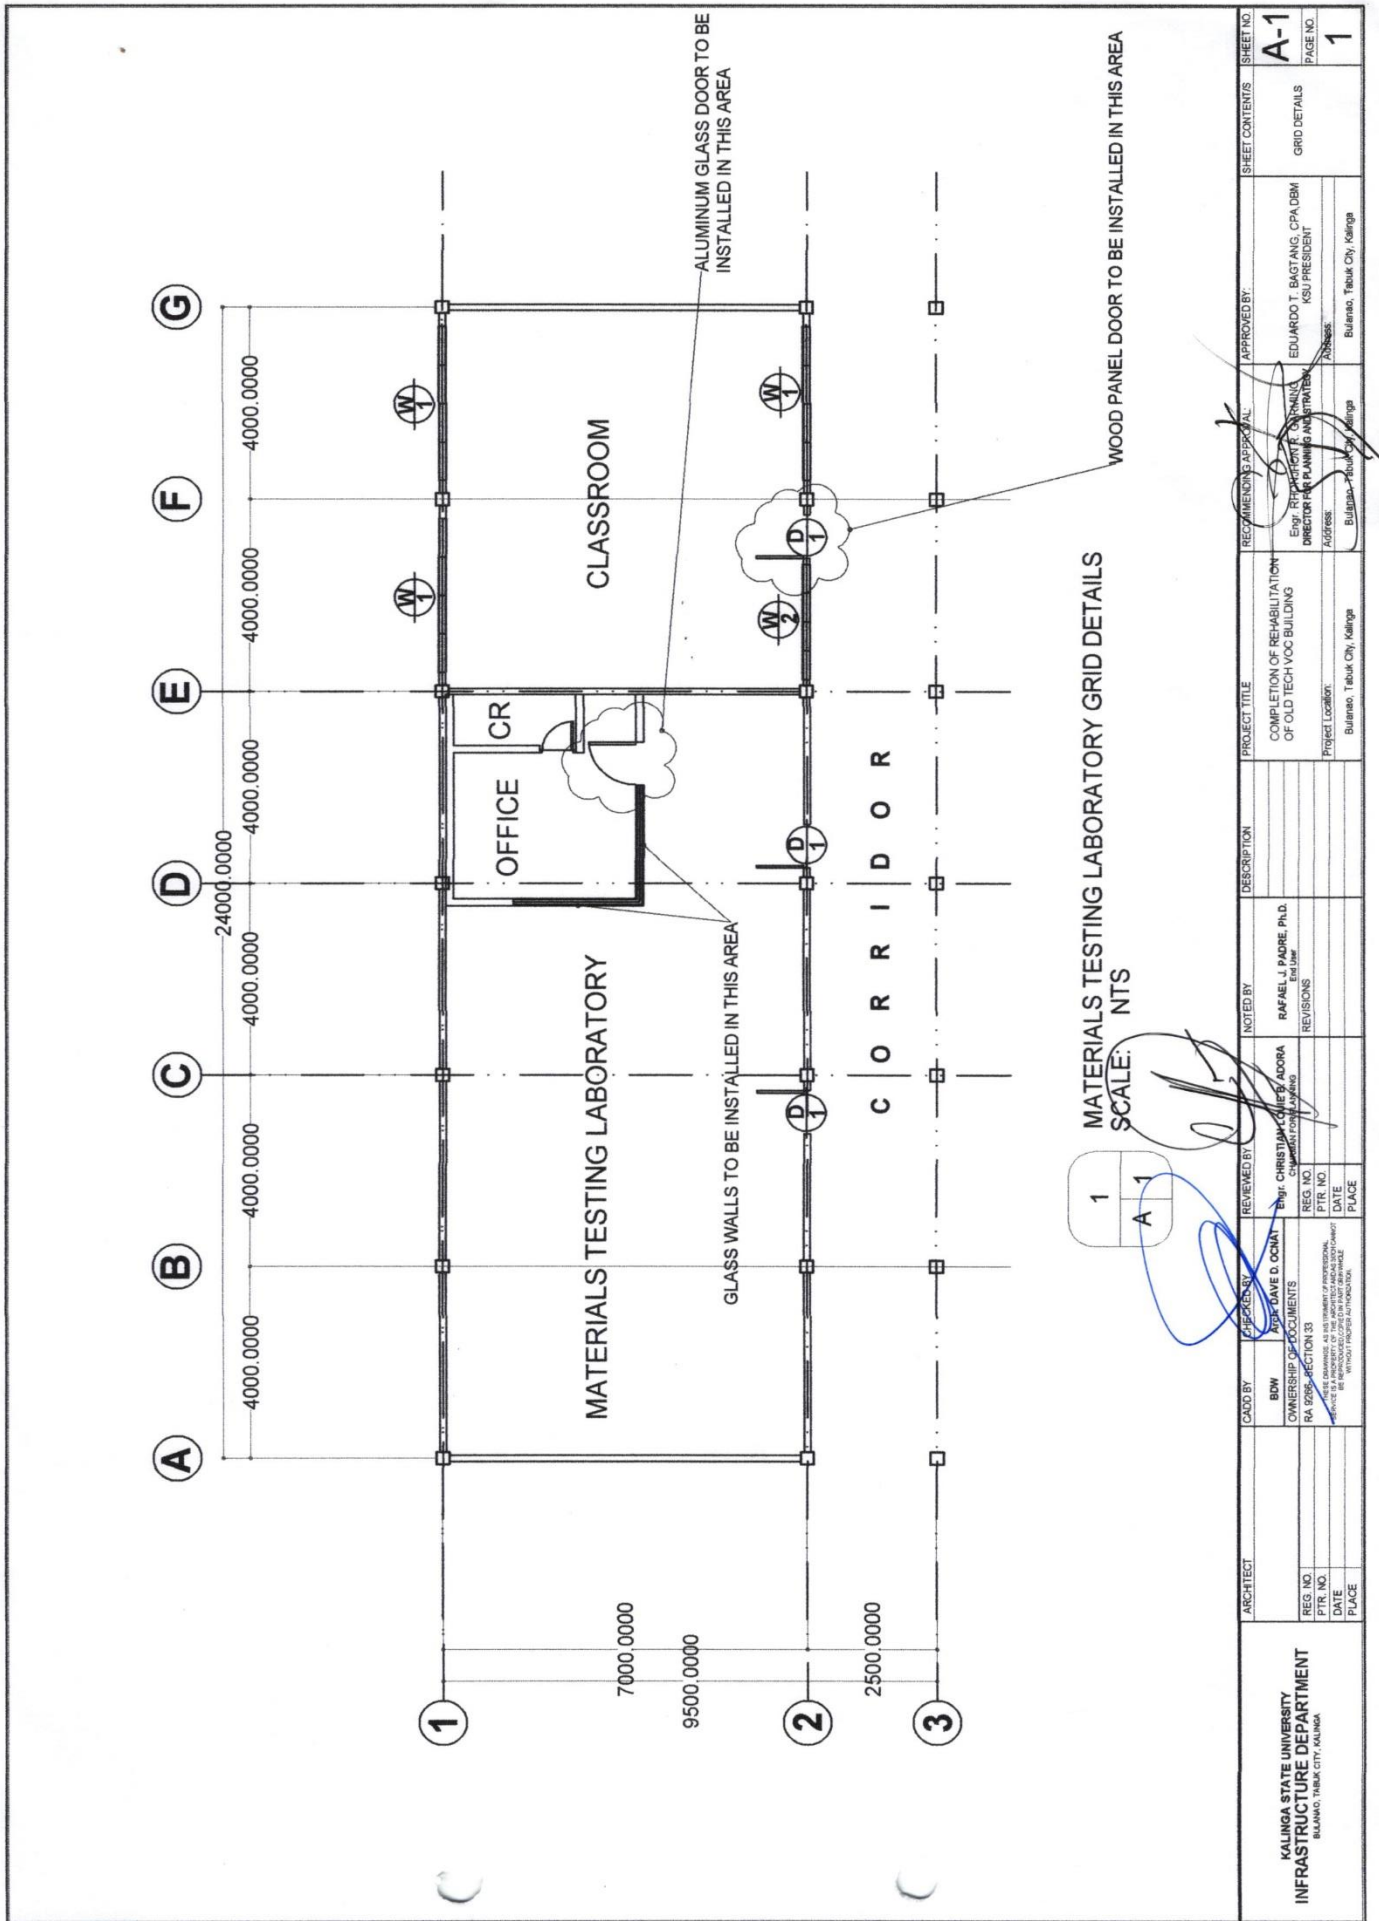

ARCHITECT	CHECKED BY	REVIEWED BY	NOTED BY	DESCRIPTION	PROJECT TITLE	RECOMMENDING APPROVAL	APPROVED BY	SHEET CONTENTS	SHEET NO.
<b>KALINGA STATE UNIVERSITY</b> <b>INFRASTRUCTURE DEPARTMENT</b> <small>BULANAO, TABUK CITY, KALINGA</small>	DR. DAVE D. OCHAI <small>REGISTERED ARCHITECT</small>	ENY. CHRISTIAN COLITE ADORA <small>REGISTERED ARCHITECT</small>	RAFAEL J. PADRE, P.L.D. <small>ENR. DIVISION CHIEF</small>	COMPLETION OF REHABILITATION OF OLD TECH-VOC BUILDING	Bulanao, Tabuk City, Kalinga	ENY. RICHARD T. ORTALDO DIRECTOR FOR PLANNING AND STRATEGIC <small>ADDRESS: Bulanao, Tabuk City, Kalinga</small>	EDUARDO T. BAGTANG, CPA, DBM KSU PRESIDENT	GRID DETAILS	<b>A-1</b> PAGE NO.
									<b>1</b> PAGE NO.

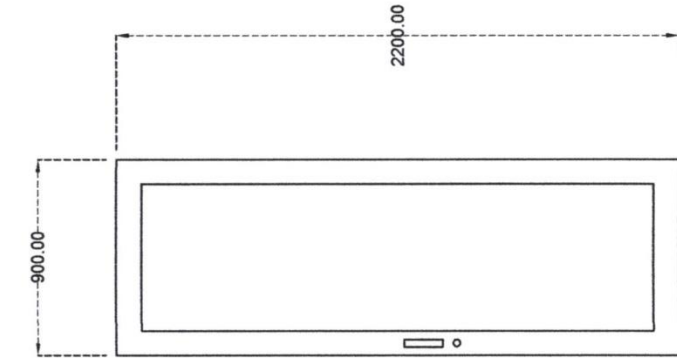


DESCRIPTION	ALUMINUM GLASS DOOR, 2200x900 6 mm THICK, CLEAR GLASS
LOCATION	MATERIALS TESTING LABORATORY OFFICE
REQUIREMENTS	1 SET
HARDWARE	COMPLETE LOCKSET COMPLETE HINGES AND ACCESSORIES

3  
A 2  
**GLASS DOOR SCHEDULE**  
 SCALE 1:20 m.




2  
A 2  
**LOCKSET DETAILS**  
 SCALE 1:2 m.

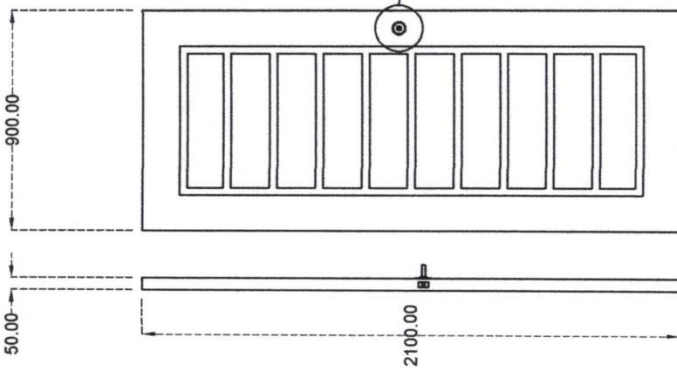

DESCRIPTION	WOOD PANEL DOOR 2100x900 WELL SEASONED DOOR, VARNISH FINISH
LOCATION	CLASSROOM BESIDE MATERIALS TESTING LABORATORY
REQUIREMENTS	1 SET
HARDWARE	HEAVY DUTY DOOR KNOB COMPLETE HINGES AND ACCESSORIES

1  
A 2  
**WOOD PANEL DOOR DETAILS**  
 SCALE 1:20 m.

<b>KALINGA STATE UNIVERSITY</b> <b>INFRASTRUCTURE DEPARTMENT</b> <small>BULANAO, TABUK CITY, KALINGA</small>	ARCHITECT REG. NO. PTR. NO. DATE PLACE	CHECKED BY BHW <small>OWNERSHIP DOCUMENTS</small> RA 8236-SECTION 33 <small>REGISTRATION AS THE INSTRUMENT OF PROFESSIONAL REGISTRATION OF ARCHITECTS</small> <small>BE REPRODUCED OR IN PART OR WHOLLY</small> <small>WITHOUT THE WRITTEN PERMISSION</small>	REVIEWED BY Engr. CHRISTIAN B. ADORA <small>REGISTERED PLANNING</small> REG. NO. PTR. NO. DATE PLACE	NOTED BY RAFAEL J. PADRE, P.E. <small>ENR. L.I.C.</small> REVISIONS	PROJECT TITLE COMPLETION OF REHABILITATION OF OLD TECH VOC BUILDING Project Location: Bulanao, Tabuk City, Kalinga	RECOMMENDATION BY Engr. RICHARD S. GARDIN DIRECTOR FOR PLANNING AND STRATEGY Address: Bulanao, Tabuk City, Kalinga	APPROVED BY: EDUARDO T. BAGTANG, CPA, DBM KSU PRESIDENT Address: Bulanao, Tabuk City, Kalinga	SHEET CONTENTS DOOR DETAILS SHEET NO. <b>A-2</b> PAGE NO. <b>2</b>
--	--	---	--	--	--	--	---	---

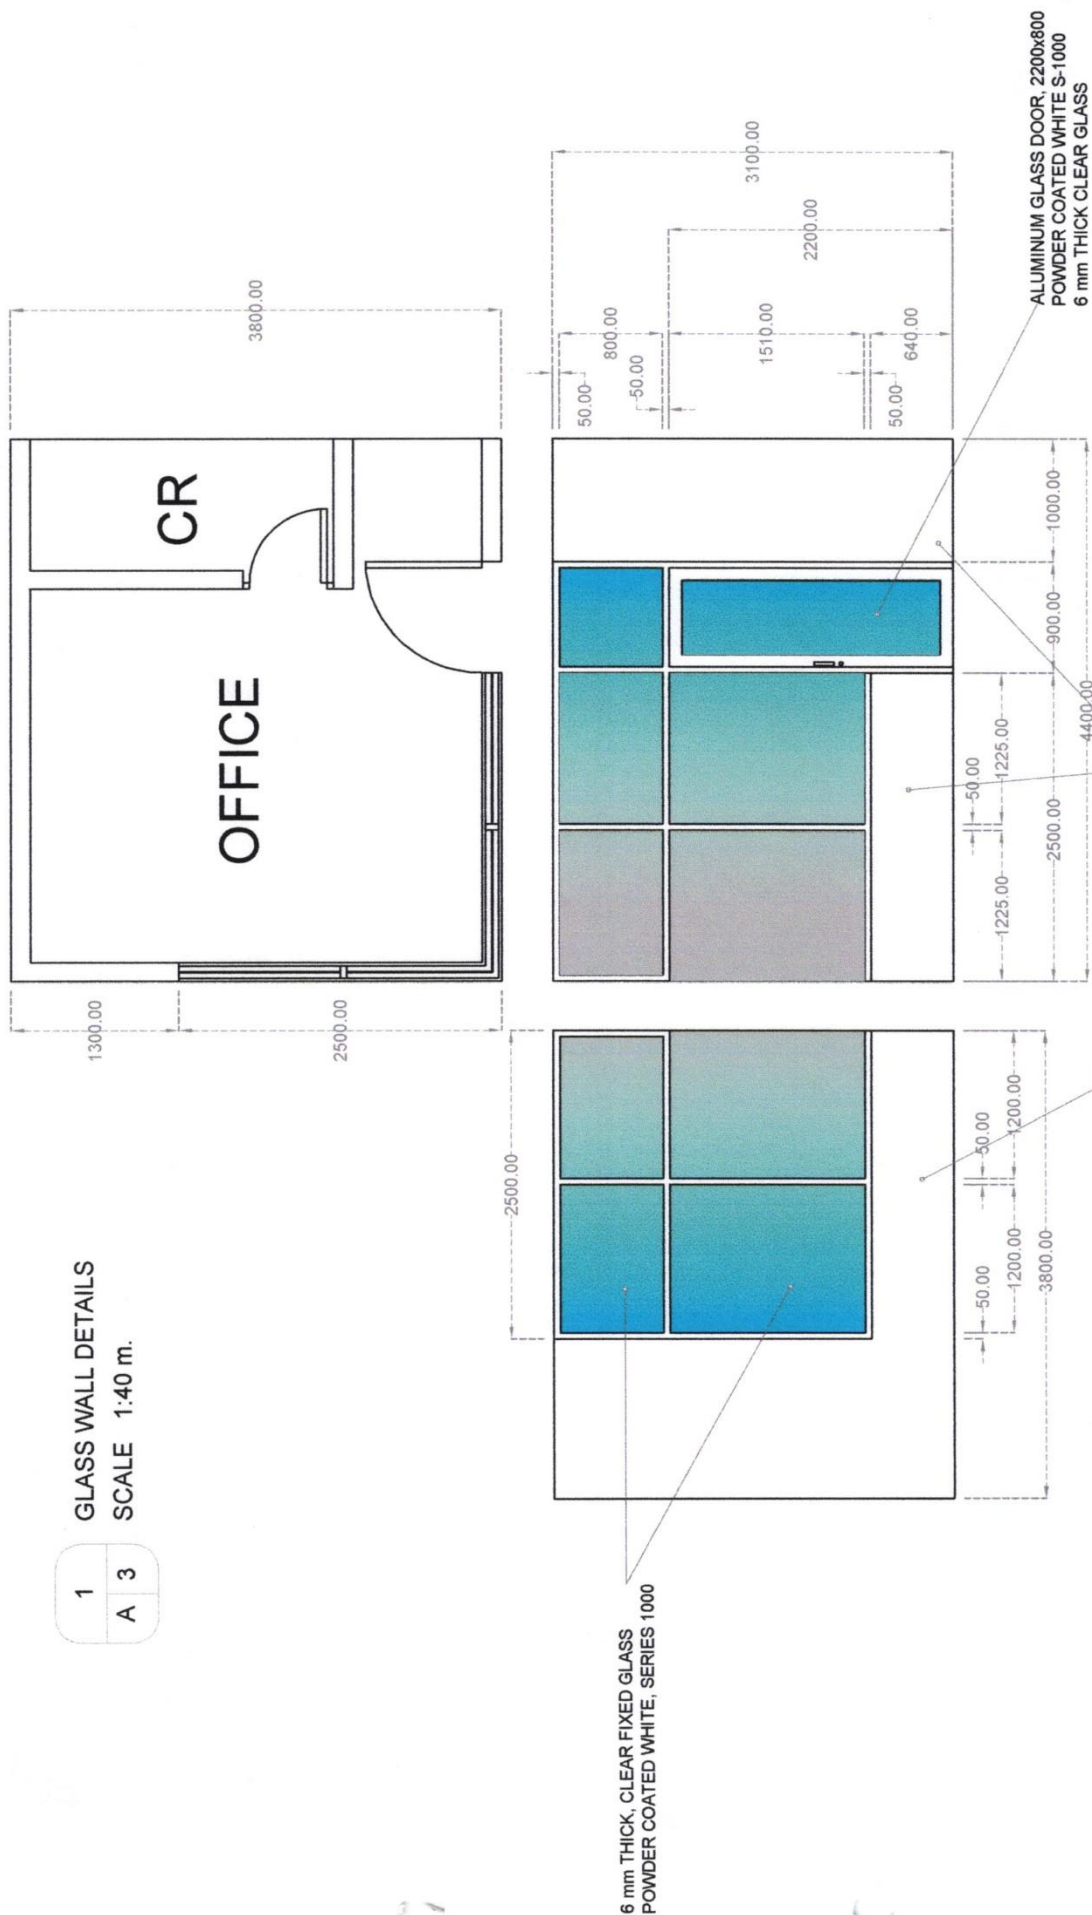


**1**  
**A 3**  
**GLASS WALL DETAILS**  
**SCALE 1:40 m.**

ARCHITECT	CADD BY	CHECKED BY	REVIEWED BY	NOTED BY	DESCRIPTION	PROJECT TITLE	RECOMMENDING APPROVAL	APPROVED BY	SHEET CONTENTS	SHEET NO.
KALINGA STATE UNIVERSITY INFRASTRUCTURE DEPARTMENT BULANAO, TABUK CITY, KALINGA	BDW OWNERSHIP DOCUMENTS RAJARES SECTION 33 BRANCH 18, BRIDGE OF THE JAMNATE PANGLOSS RE-REPAIR OF THE EXISTING CONCRETE STRUCTURE	PROF. DAVE D. OCHIAI	Engr. CHRISTIAN LOUIS A. ADORA Chairman for RAJARES	RAFAEL J. PADRE, Ph.D. Engr. (Structural) / Engr. (Civil) REVISIONS	COMPLETION OF REHABILITATION OF OLD TECH-VOC BUILDING Project Location: Bulanao, Tabuk City, Kalinga	COMPLETION OF REHABILITATION OF OLD TECH-VOC BUILDING Project Location: Bulanao, Tabuk City, Kalinga	ENR. CHRISTIAN LOUIS A. ADORA DIRECTOR FOR PLANNING AND STRATEGY Address: Bulanao, Tabuk City, Kalinga	EDUARDO T. BAGTANG, CPA, CBM KSU PRESIDENT Address: Bulanao, Tabuk City, Kalinga	GLASS WALL DETAILS	A-3 PAGE NO. 3





Republic of the Philippines  
**KALINGA STATE UNIVERSITY**  
**BIDS AND AWARDS COMMITTEE**  
 National Highway, Purok 6, Bulanao, Tabuk City, Kalinga  
 Website: <https://ksu.edu.ph> Email: [procurementservice\\_bac@ksu.edu.ph](mailto:procurementservice_bac@ksu.edu.ph) CPNo.: 0917-774-4185

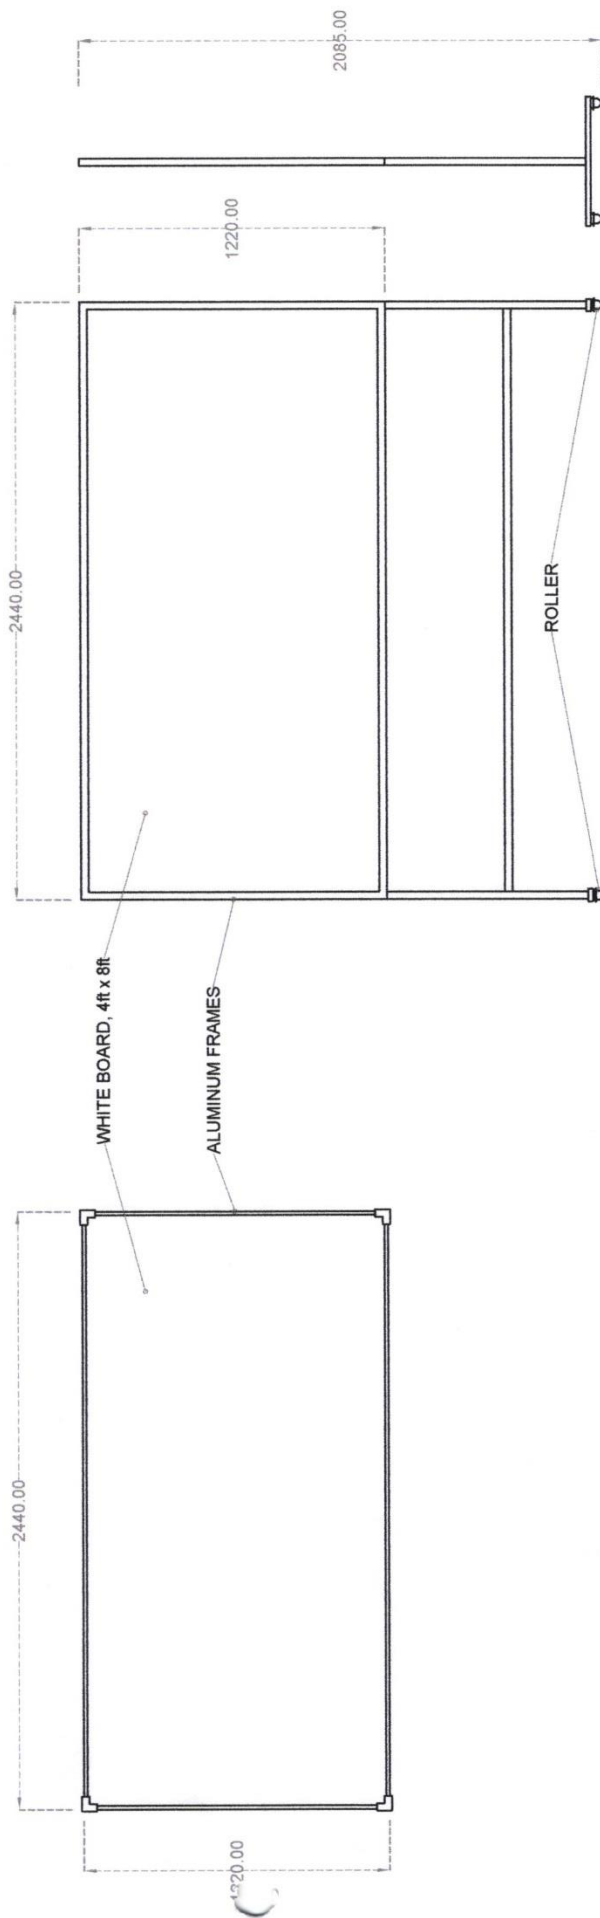

1 WHITE BOARD DETAILS  
 SCALE 1:20 m.

2 WHITE BOARD WITH ROLLER DETAILS  
 SCALE 1:20 m.


2  
A 4

1  
A 4

<b>KALINGA STATE UNIVERSITY</b> <b>INFRASTRUCTURE DEPARTMENT</b> BULANAO, TABUK CITY, KALINGA	ARCHITECT	BOM COMBERSHIP SECTION 20 FOR PROPOSED REPAIRS AND MAINTENANCE SERVICES IN THE UNIVERSITY OF THE EAST PHILIPPINES (UPEP) - BULANAO CAMPUS	CHECKED BY ENGR. CHRISTIAN MARIE B. JODORA REGISTERED PROFESSIONAL ENGINEER CIVIL ENGINEERING	NOTED BY RAFAEL J. PADRE, P.A.D. REGISTERED PROFESSIONAL ARCHITECT REVISIONS	DESCRIPTION	PROJECT TITLE COMPLETION OF REHABILITATION OF OLD TECH-VOC BUILDING Project Location Bulanao, Tabuk City, Kalinga	RECOMMENDING APPROVAL ENGR. EDUARDO T. BAGTANG, CPA, DBM DIRECTOR FOR PLANNING AND INVENTORY Address Bulanao, Tabuk City, Kalinga	APPROVED BY: EDUARDO T. BAGTANG, CPA, DBM KSU PRESIDENT Address Bulanao, Tabuk City, Kalinga	SHEET CONTENTS WHITE BOARD DETAIL	SHEET NO. <b>A-4</b> PAGE NO. <b>4</b>
---	-----------	---	--	---	-------------	--	---	--	--------------------------------------	---



Republic of the Philippines  
**KALINGA STATE UNIVERSITY**  
**BIDS AND AWARDS COMMITTEE**  
 National Highway, Purok 6, Bulanao, Tabuk City, Kalinga  
 Website: <https://ksu.edu.ph> Email: [procurementservice\\_bac@ksu.edu.ph](mailto:procurementservice_bac@ksu.edu.ph) CPNo.: 0917-774-4185

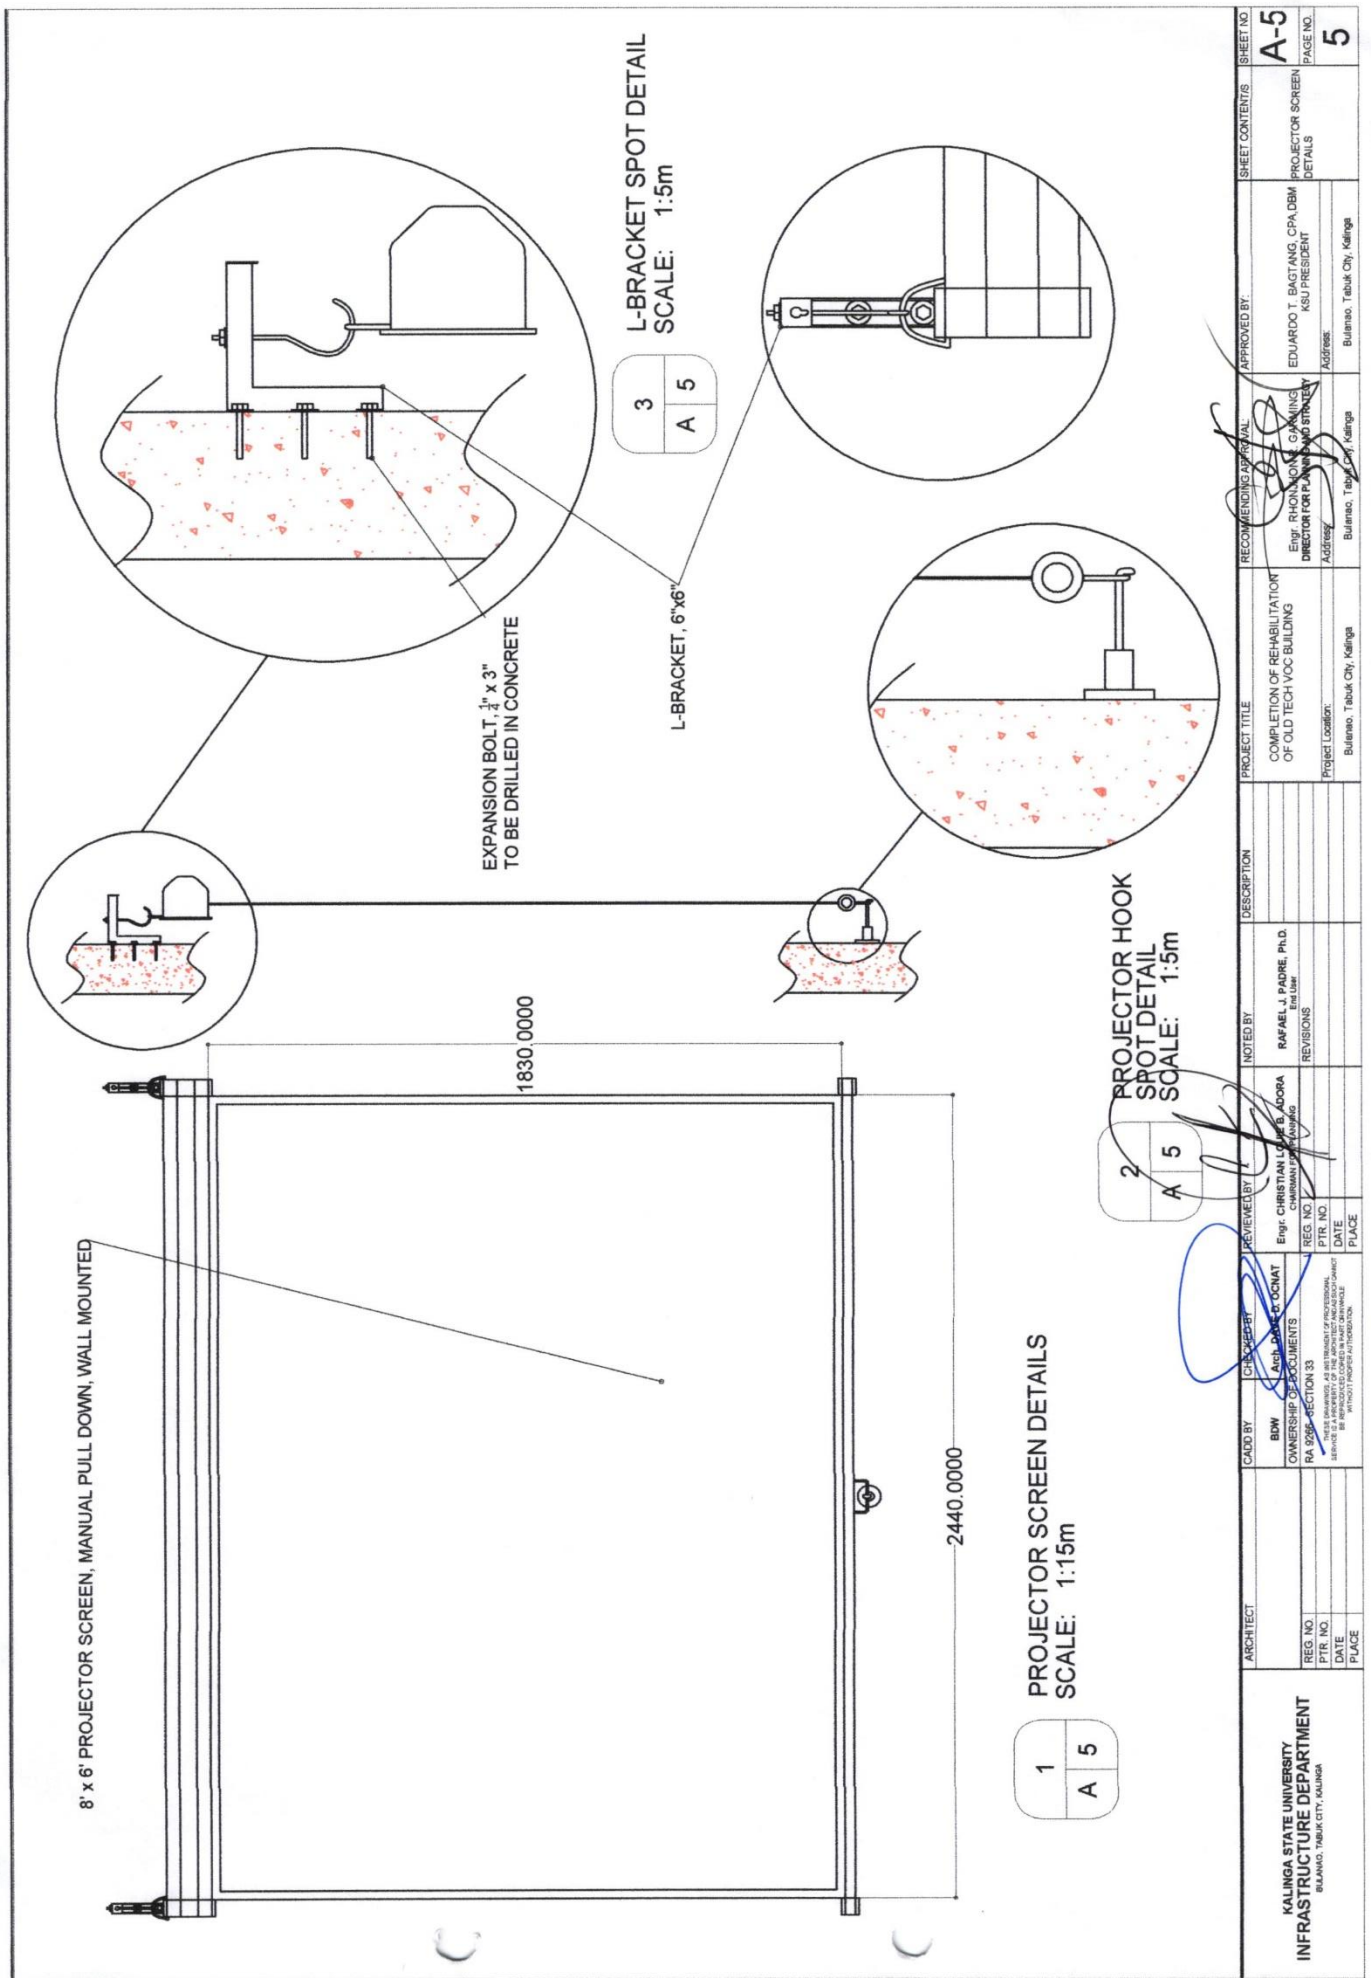

<b>KALINGA STATE UNIVERSITY</b> INFRASTRUCTURE DEPARTMENT <small>BULANAO, TABUK CITY, KALINGA</small>	ARCHITECT REG. NO. _____ PTR. NO. _____ DATE _____ PLACE _____	CADD BY <b>BDW</b> OWNERSHIP OF DOCUMENTS <b>RA 9266-SECTION 33</b> <small>ARTIST'S DRAWINGS ARE THE PROPERTY OF PROFESSIONALS AND SHOULD NOT BE REPRODUCED OR COPIED IN ANY MANNER WITHOUT PROFESSIONAL INTERVENTION.</small>	CHECKED BY <b>Arch. JAMES D. OCHAT</b>	REVIEWED BY Engr. CHRISTIAN LUIS B. ADORA <small>CHIEF ENGINEER (MAYNAG)</small>	NOTED BY <b>RAFAEL J. PADRE, Ph.D.</b> <small>Enr. (E)</small>	DESCRIPTION COMPLETION OF REHABILITATION OF OLD TECH-VOC BUILDING	PROJECT TITLE COMPLETION OF REHABILITATION OF OLD TECH-VOC BUILDING	RECOMMENDING APPROVAL Engr. RHONALDO G. GANING DIRECTOR FOR PLANNING AND STRATEGY	APPROVED BY EDUARDO T. BAGTANG, CPA, DBM KSU PRESIDENT	SHEET CONTENTS PROJECTOR SCREEN DETAILS	SHEET NO. <b>A-5</b>
	PROJECT LOCATION Bulanao, Tabuk City, Kalinga	PROJECT LOCATION Bulanao, Tabuk City, Kalinga	PROJECT LOCATION Bulanao, Tabuk City, Kalinga	PROJECT LOCATION Bulanao, Tabuk City, Kalinga	PROJECT LOCATION Bulanao, Tabuk City, Kalinga	PROJECT LOCATION Bulanao, Tabuk City, Kalinga	PROJECT LOCATION Bulanao, Tabuk City, Kalinga	PROJECT LOCATION Bulanao, Tabuk City, Kalinga	PROJECT LOCATION Bulanao, Tabuk City, Kalinga	PROJECT LOCATION Bulanao, Tabuk City, Kalinga	PROJECT LOCATION Bulanao, Tabuk City, Kalinga





Republic of the Philippines  
**KALINGA STATE UNIVERSITY**  
**BIDS AND AWARDS COMMITTEE**  
 National Highway, Purok 6, Bulanao, Tabuk City, Kalinga  
 Website: <https://ksu.edu.ph> Email: [procurementservice\\_bac@ksu.edu.ph](mailto:procurementservice_bac@ksu.edu.ph) CPNo.: 0917-774-4185

**1 WINDOW 1 DETAILS**  
SCALE: 1:15

3 SETS OF 3200 mm x 1500 mm SLIDING GLASS WINDOW  
6 mm THICK TINTED GLASS, WITH INTERNAL GRILLS  
ANALOK FRAMES

3200.00

1500.00

**2 WINDOW 2 DETAILS**  
SCALE: 1:15

1 SET OF 2400 mm x 1500 mm SLIDING GLASS WINDOW  
6 mm THICK TINTED GLASS, WITH INTERNAL GRILLS  
ANALOK FRAMES


2400.00

1500.00

ARCHITECT	CADD BY	CHECKED BY	NOTED BY	DESCRIPTION	PROJECT TITLE	RECOMMENDING OFFICIAL	APPROVED BY	SHEET CONTENTS	SHEET NO.
KALINGA STATE UNIVERSITY INFRASTRUCTURE DEPARTMENT BULANA, TABUK CITY, KALINGA	BDW OWNER/SUPPLIER OF DOCUMENTS FA 2008-SECTION 33 RENDERED AS A SERVICE OF THE UNIVERSITY OF KALINGA RENDERED BY THE UNIVERSITY OF KALINGA RENDERED FOR THE UNIVERSITY OF KALINGA	DR. DAVID D. OCHAY ENGR. CHRISTIAN LOPEZ B. ADORAK ENGR. CHRYSTIAN LOPEZ B. ADORAK	RAFAEL J. PADRE, PH.D. End User REVISIONS	COMPLETION OF REHABILITATION OF OLD TECH VOC BUILDING	Engr. RICHARD M. GARRING DIRECTOR FOR PLANNING AND STUDENT AFFAIRS	EDUARDO T. BAGTANG, CPA, DBM KSU PRESIDENT		WINDOW DETAILS	A-6
				Project Location: Bulanao, Tabuk City, Kalinga	Bulanao, Tabuk City, Kalinga	Bulanao, Tabuk City, Kalinga			6



Republic of the Philippines  
**KALINGA STATE UNIVERSITY**  
**BIDS AND AWARDS COMMITTEE**  
 National Highway, Purok 6, Bulanao, Tabuk City, Kalinga  
 Website: <https://ksu.edu.ph> Email: [procurementservice\\_bac@ksu.edu.ph](mailto:procurementservice_bac@ksu.edu.ph) CPNo.: 0917-774-4185

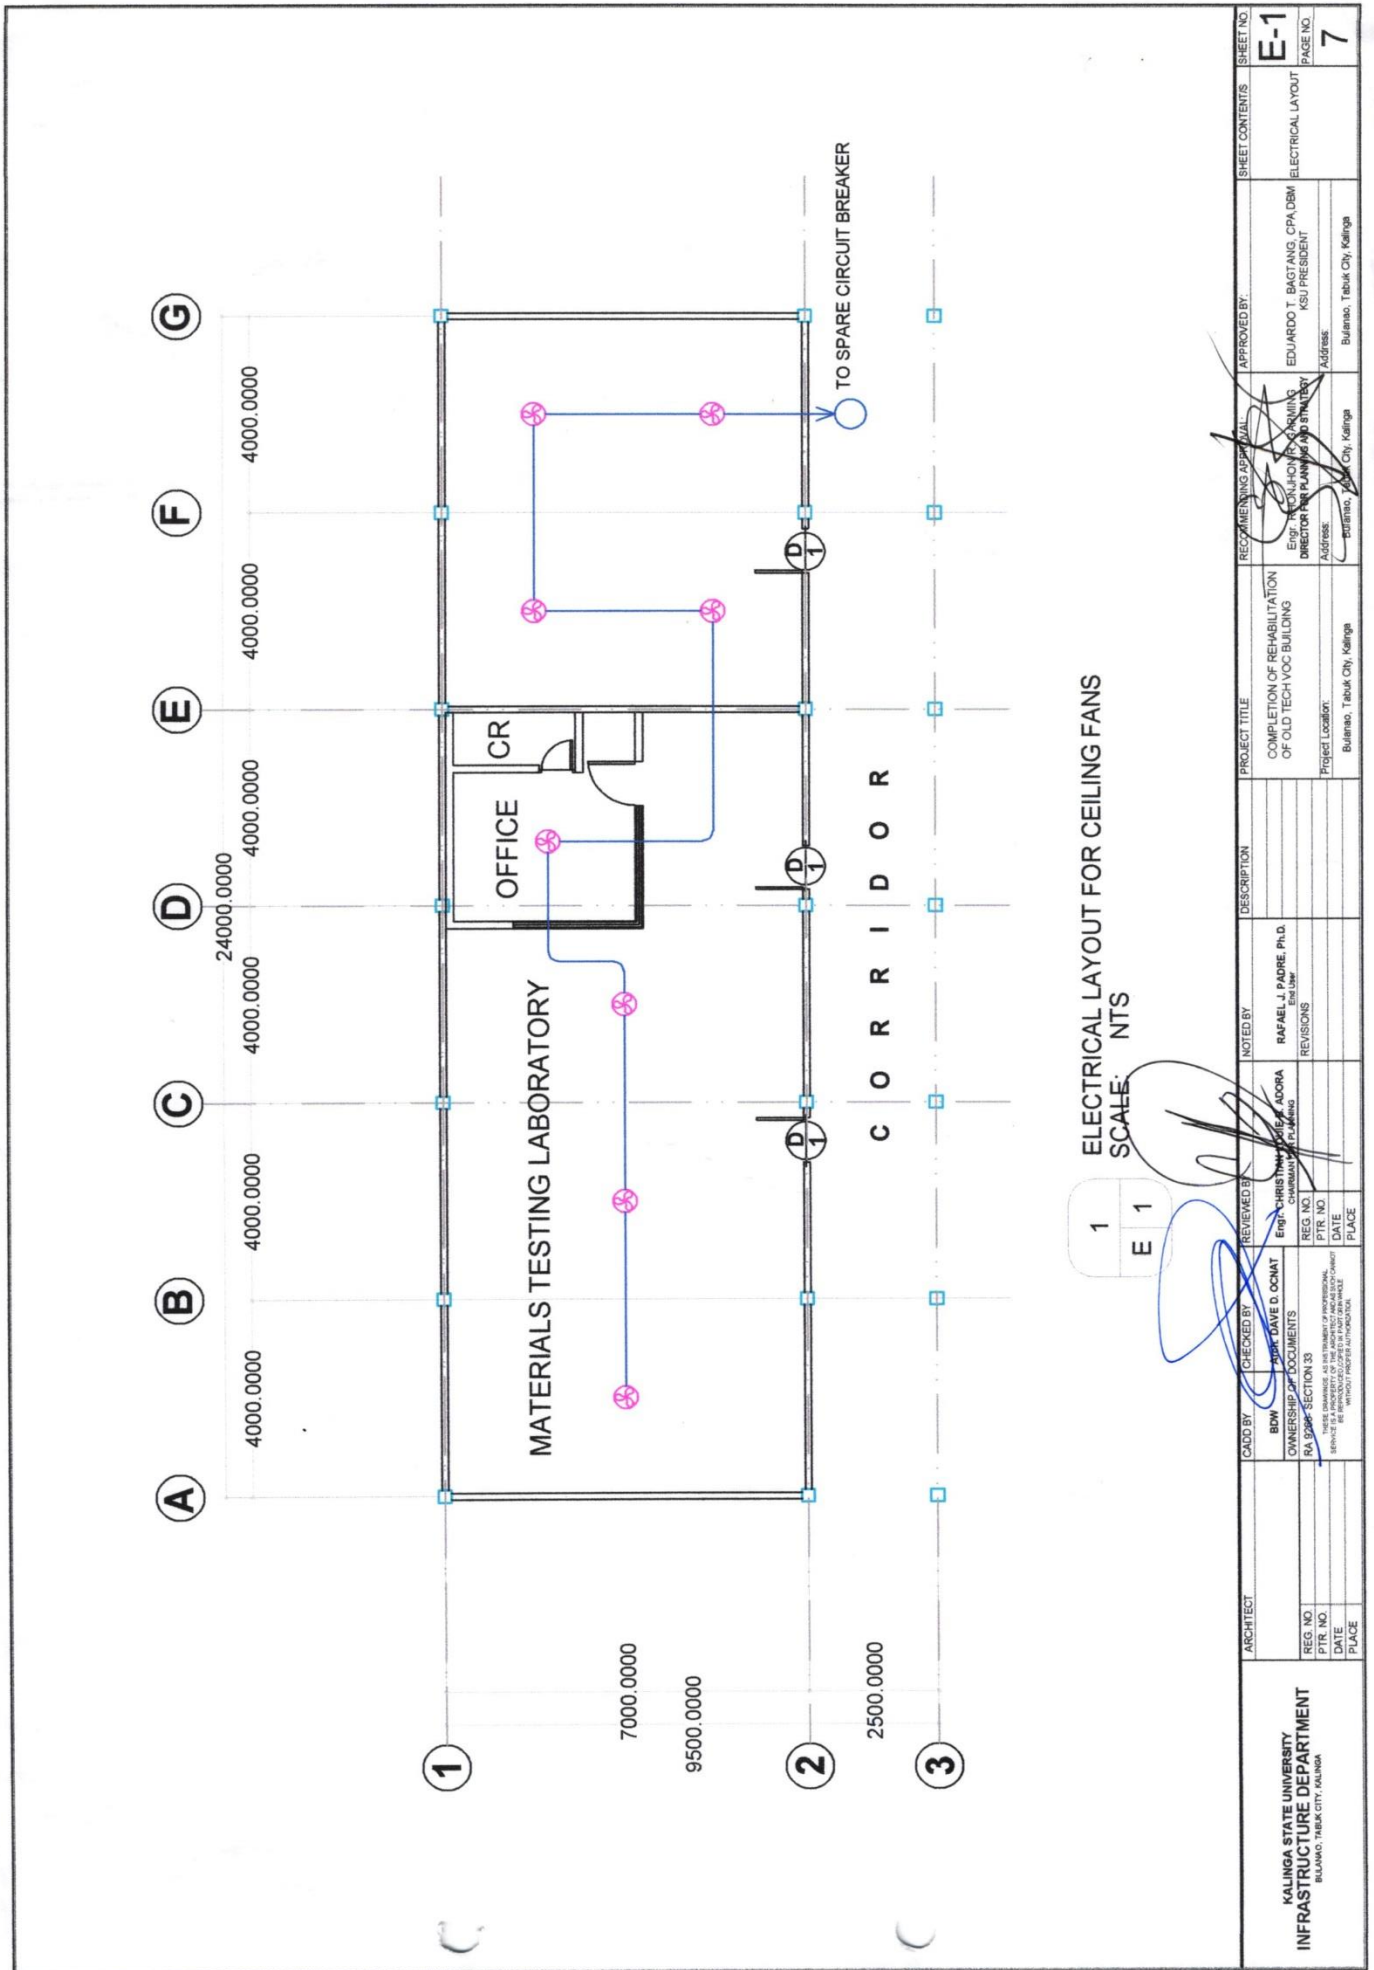

1  
 E 1

ARCHITECT	CHECKED BY	REVIEWED BY	NOTED BY	DESCRIPTION	PROJECT TITLE	RECOMMENDING APPROVAL	APPROVED BY:	SHEET CONTENTS	SHEET NO.
KALINGA STATE UNIVERSITY INFRASTRUCTURE DEPARTMENT BULANAO, TABUK CITY, KALINGA	BOW OWNER'S REPRESENTATIVE RA 9184 SECTION 33 <small>THIS DRAWING IS INSTRUMENT OF PROFESSIONAL SERVICE AND NOT TO BE REPRODUCED OR TRANSMITTED IN ANY FORM OR BY ANY MEANS WITHOUT THE WRITTEN PERMISSION OF THE ARCHITECT.</small>	DAVE D. OCMAT ENR. REGISTERED PROFESSIONAL ENGINEER REG. NO. [blank] PTR. NO. [blank] DATE [blank] PLACE [blank]	RAFAEL J. PADRE, P.L.D. ENR. REGISTERED PROFESSIONAL ELECTRICAL ENGINEER REG. NO. [blank] PTR. NO. [blank] DATE [blank] PLACE [blank]	COMPLETION OF REHABILITATION OF OLD TECH-VOC BUILDING Project Location: Bulanao, Tabuk City, Kalinga	COMPLETION OF REHABILITATION OF OLD TECH-VOC BUILDING Project Location: Bulanao, Tabuk City, Kalinga	ENR. CHRISTOPHER S. AQUINO DIRECTOR FOR PLANNING AND STUDIES Address: Bulanao, Tabuk City, Kalinga	EDUARDO T. BAGTANG, CPA, DBM KSU PRESIDENT Address: Bulanao, Tabuk City, Kalinga	ELECTRICAL LAYOUT	E-1 PAGE NO. 7